


SYMBOL LEGEND

- SURFACE MOUNTED LIGHT FIXTURE MAX 100W BULBS
- RECESSED MOUNTED LIGHT FIXTURE MAX 100W BULBS
- CEILING HUNG LIGHT FIXTURE MAX 100W BULBS
- SURFACE MOUNTED INCANDESCENT VANITY LIGHT FIXTURE (3) MAXIMUM 100W BULBS
- RECESSED EXHAUST FAN MINIMUM 80 CFM
- DUPLEX RECEPTICAL OUTLET, GFI IF INDICATED
- ELECTRICAL CONNECTION
- ELECTRICAL WALL SWITCH, NUMBER INDICATES DEVICE
- SMOKE AND CARBON MONOXIDE DETECTOR HARD WIRED
- TELEPHONE JACK
- THERMOSTAT CONTROL
- DOOR BELL
- EXTERIOR FLOOD LIGHT FIXTURE (2) MAXIMUM 100W BULBS
- CEILING HUNG FAN LIGHT
- FLUSH MOUNTED RETURN AIR VENT
- AIR DIFFUSER


WALL LEGEND

- POURED CONCRETE WALL
- 2 X 4 WOOD STUD WALL @ 16" O.C. W/ 1/2" GYPSUM BD. ON EACH SIDE.
- 2X4 OR 2X6 WOOD STUD WALL @16" O.C W/ 1/2" GYP BD. ON INT. AND 1/2" CDX PLY ON EXT. WITH 1" RIGID INSULATION BOARD WITH DRYVIT FINISH SYSTEM AND 3 1/2" BATT MIN. INSULATION R=15 AND VAPOR BARRIER ON INT. SIDE
- 2 X 4 WOOD STUD WALL @ 16" O.C. W/ 5/8" FIRE RESISTIVE GYPSUM BD. TYPE "C" ON EACH SIDE AND 3 1/2" BATT INSULATION R=15 1 HR RATED WALL. GA WP3605, UL U305, ULC W301
- 2 X 4 WOOD STUD WALL @16" O.C. W/ 1/2" WATER RESISTIVE BD. ON WET SIDE AND 1/2" GYPSUM BD. ON DRY SIDE.
- EXISTING WALL
- WALL TO BE REMOVED

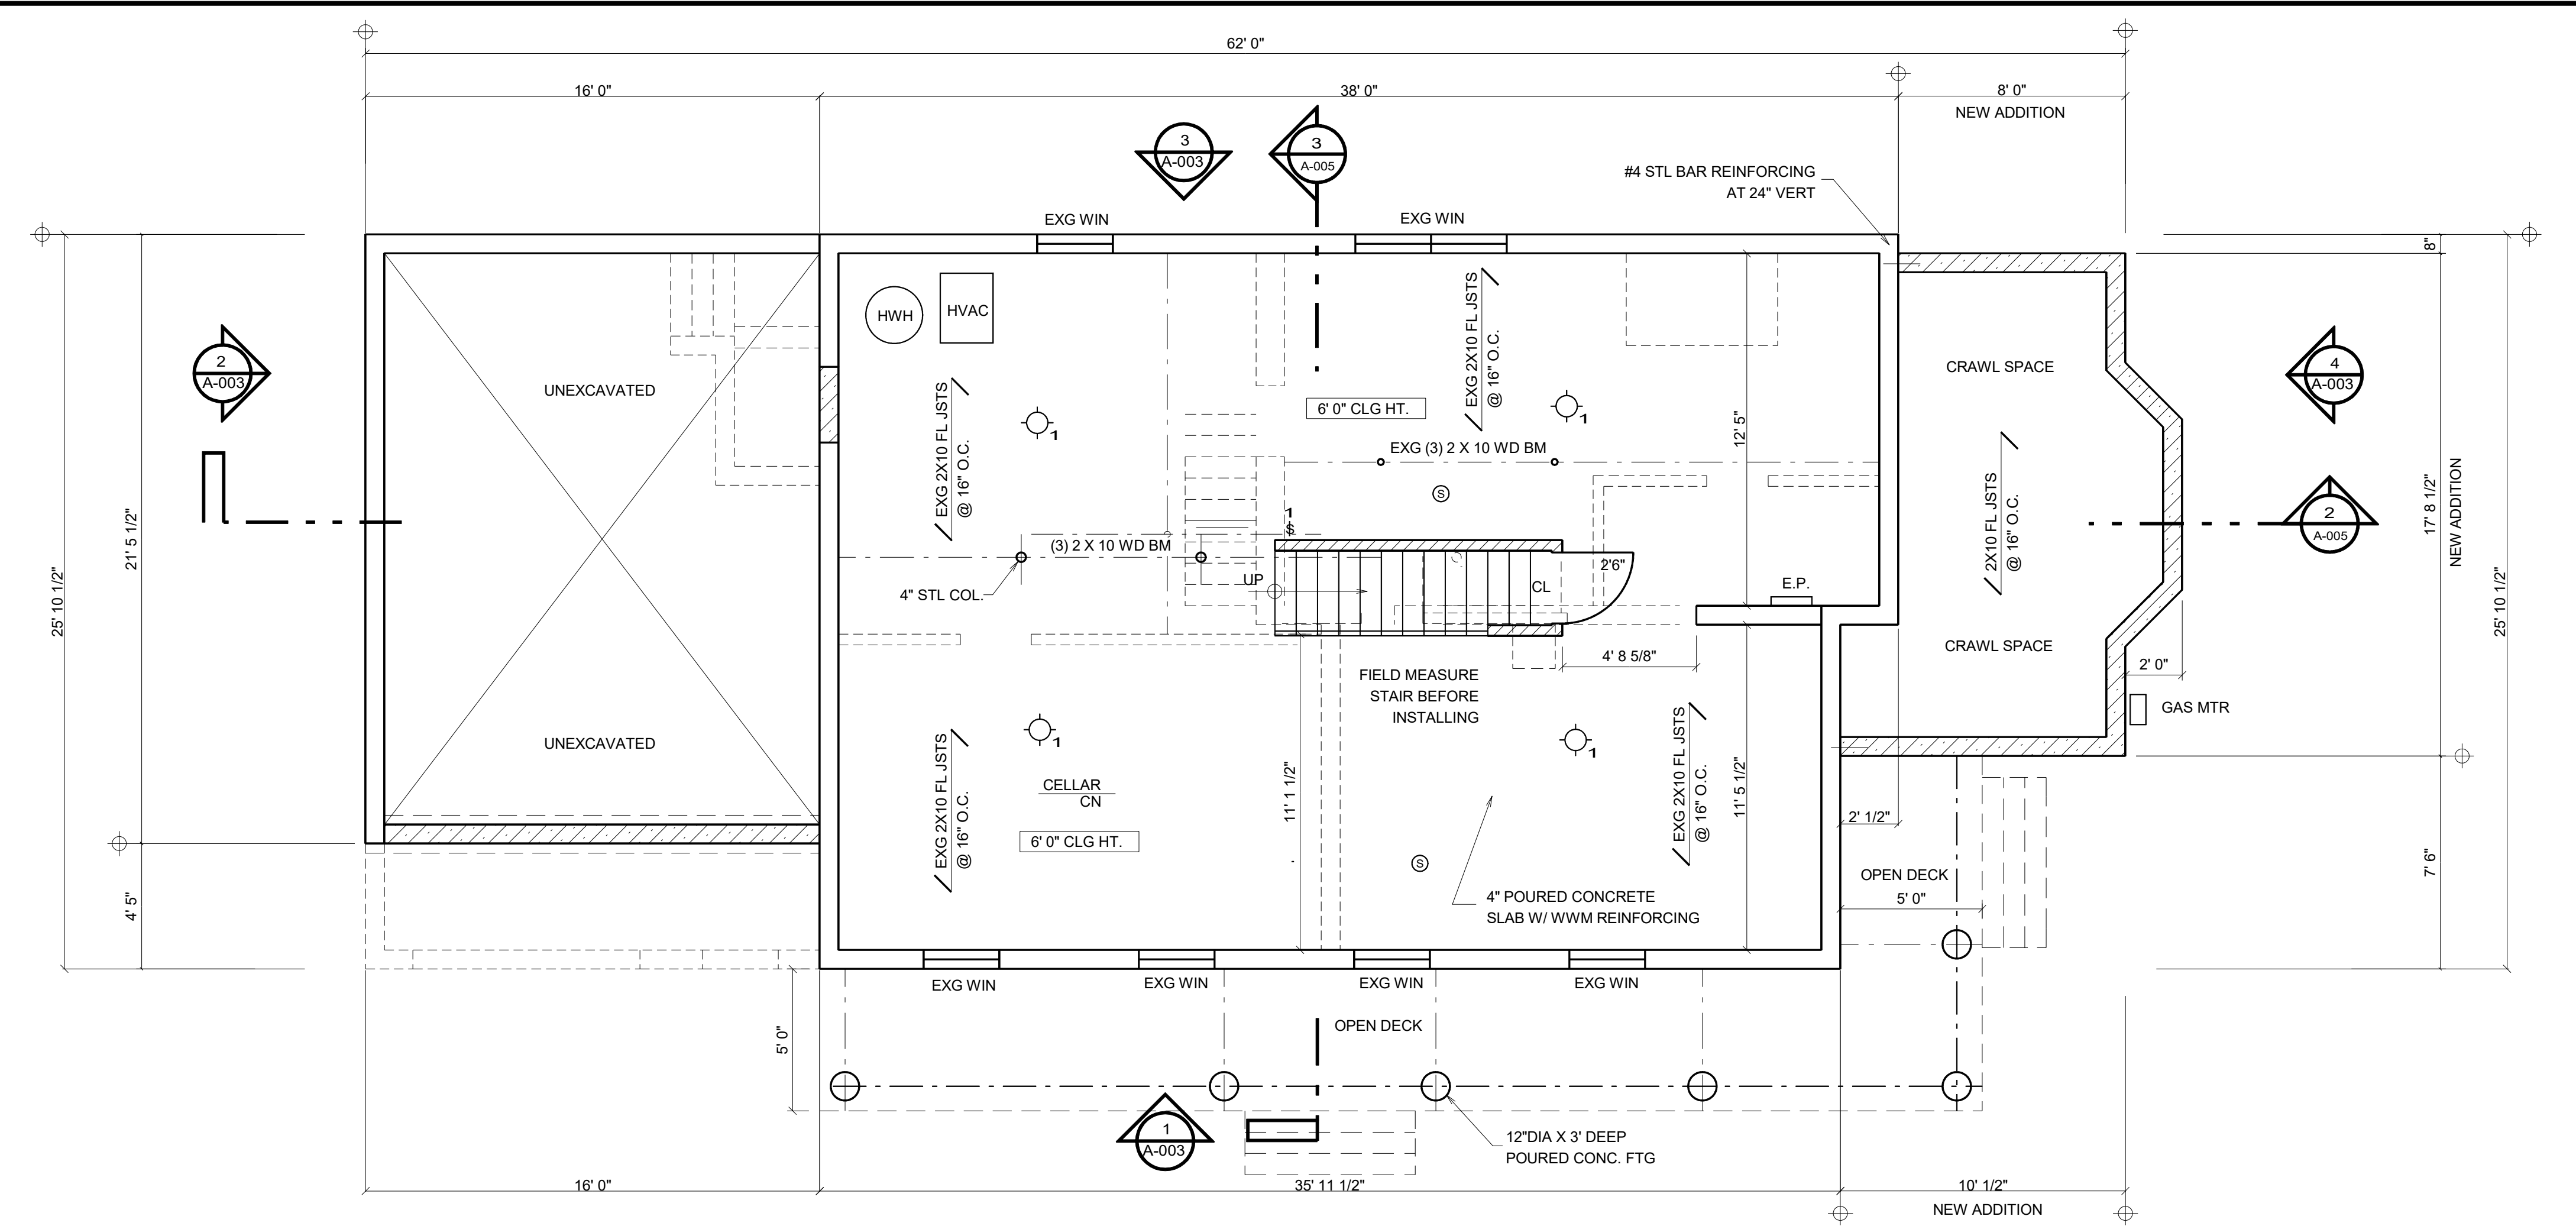

1 CELLAR FLOOR PLAN

SCALE: 1/4"=1'-0"

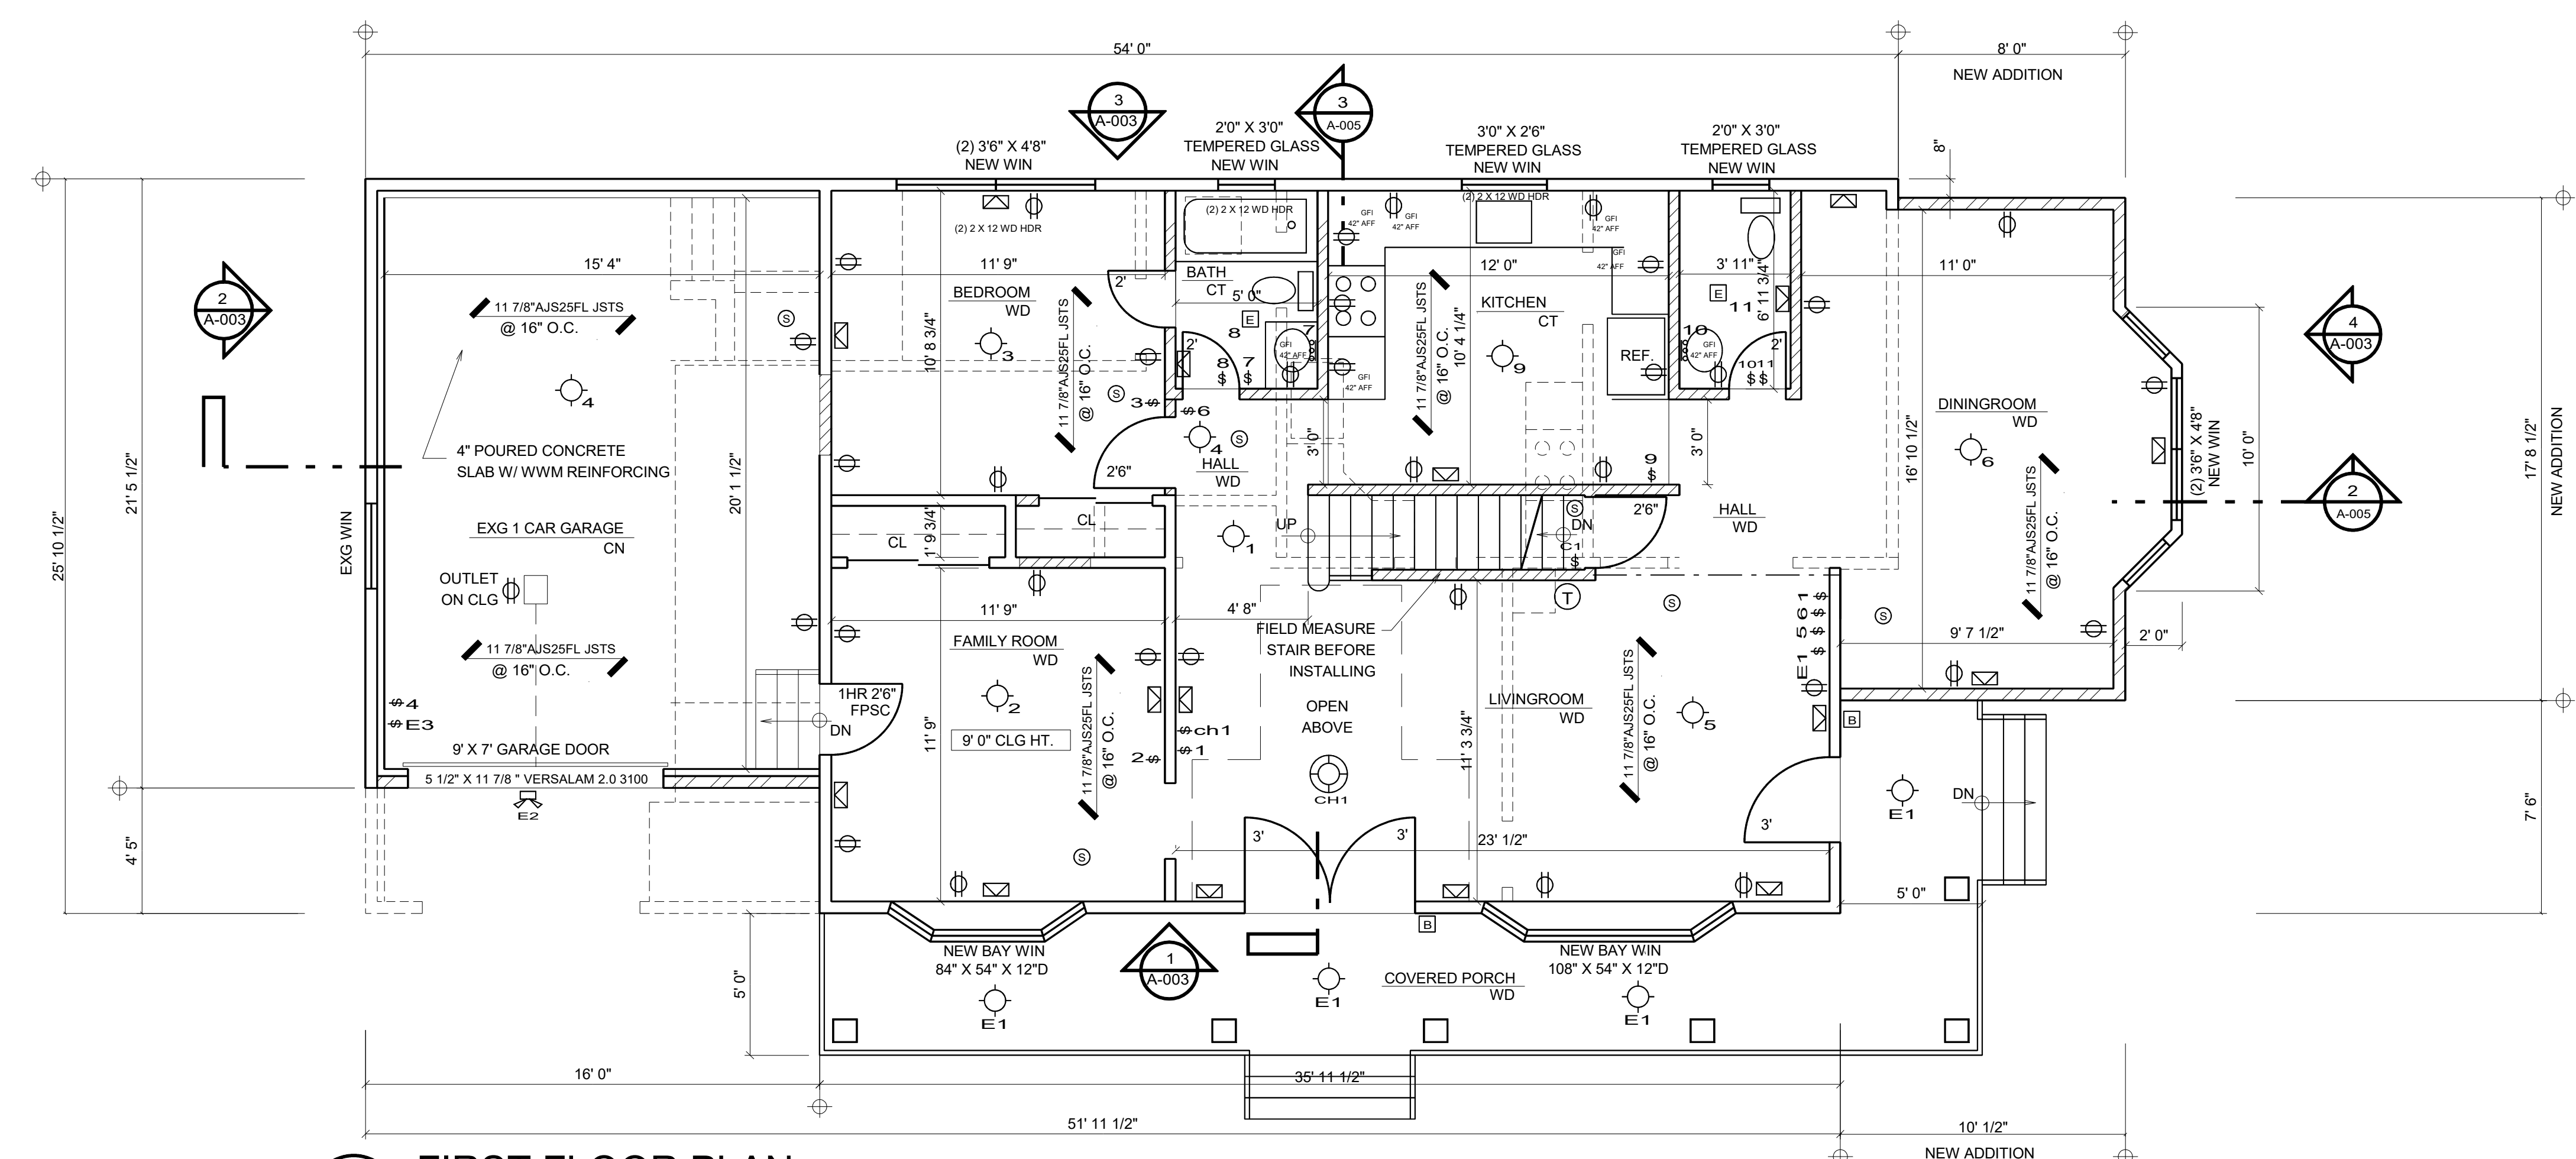

2 FIRST FLOOR PLAN

SCALE: 1/4"=1'-0"

JOHN RIGGIO, RA ARCHITECT		PROJECT NO. 202133
172 MAIN STREET, SUITE 33 METUCHEN, NJ 08840 TEL/FAX: (732) 902-2882		DRAWN BY J.R.
		SCALE 1/4" = 1'-0"
SEAL	THE LAW PROHIBITS THE ALTERING OF THIS DOCUMENT TO CHANGE THE DOCUMENT. THERE MUST BE A LICENSED ARCHITECT PRESENT AND ABLE TO SEAL IT.	DATE 4-27-2022
PROJECT ADDITION AND ALTERATION TO ONE FAMILY HOUSE 328 DURHAM AVENUE METUCHEN, NJ 08840	TITLE CELLAR AND FIRST FLOOR PLANS	DRAWING A-001.00 2 OF 6