



1 FOOTING DETAIL
SCALE: 1/2" = 1'-0"

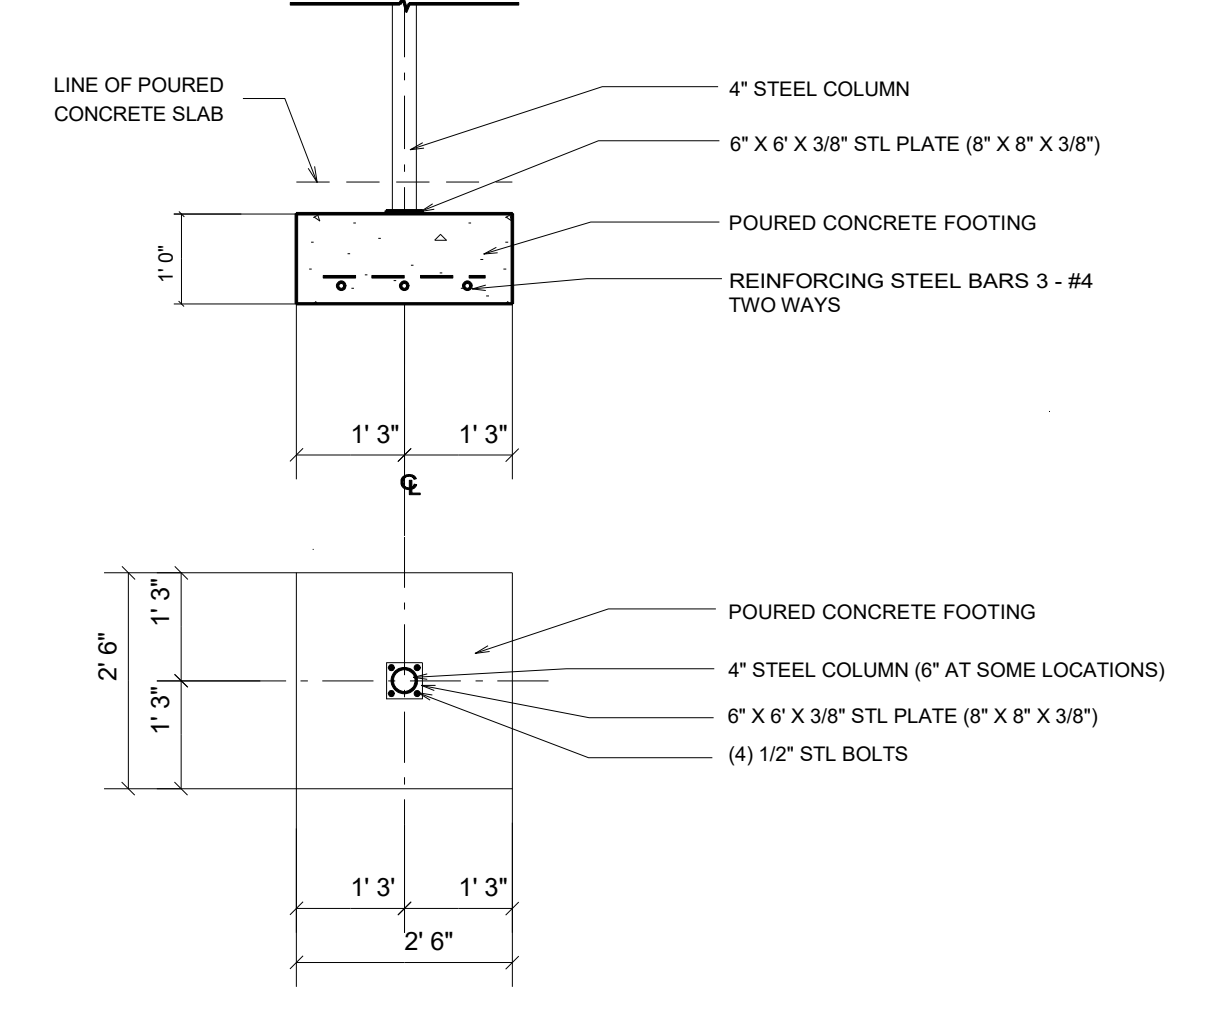


2 COLUMN FTG DETAIL
SCALE: 1/2" = 1'-0"

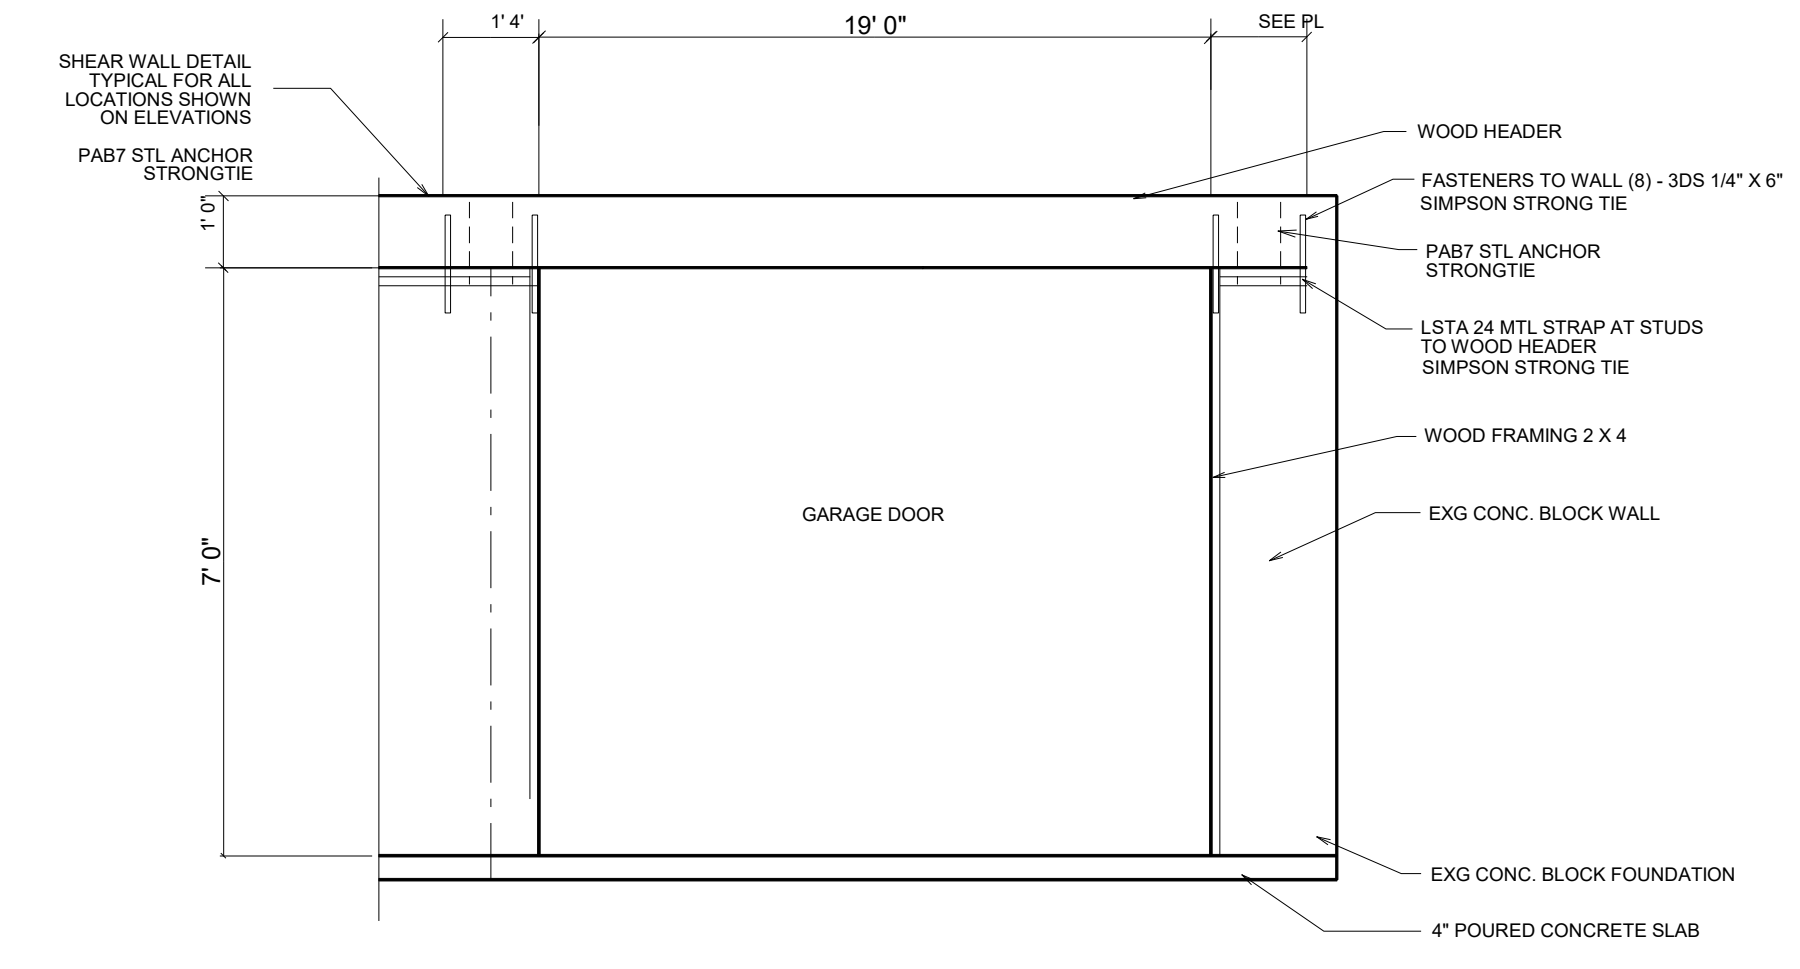


3 SHEAR WALL DETAIL
SCALE: 3/8" = 1'-0"

SHEAR WALL NOTES

TYPICAL SHEAR WALL ASSEMBLY
SIMPSON STRONG TIE MODEL # SW100B4
WIDTH = 16" HEIGHT = 60" THICKNESS = 4"
(8) - 3DS 1/4" X 6" NUMBER OF FASTENERS IN BOTTOM OF WALL
(2) - 5/8" DIA HULLS ANCHORS
(2) - 7/8" DIA HOLD DOWN ANCHOR BOLTS
LSTA 24 MTL STRAP AT CORNERS OF FLYWOOD SHEATHING

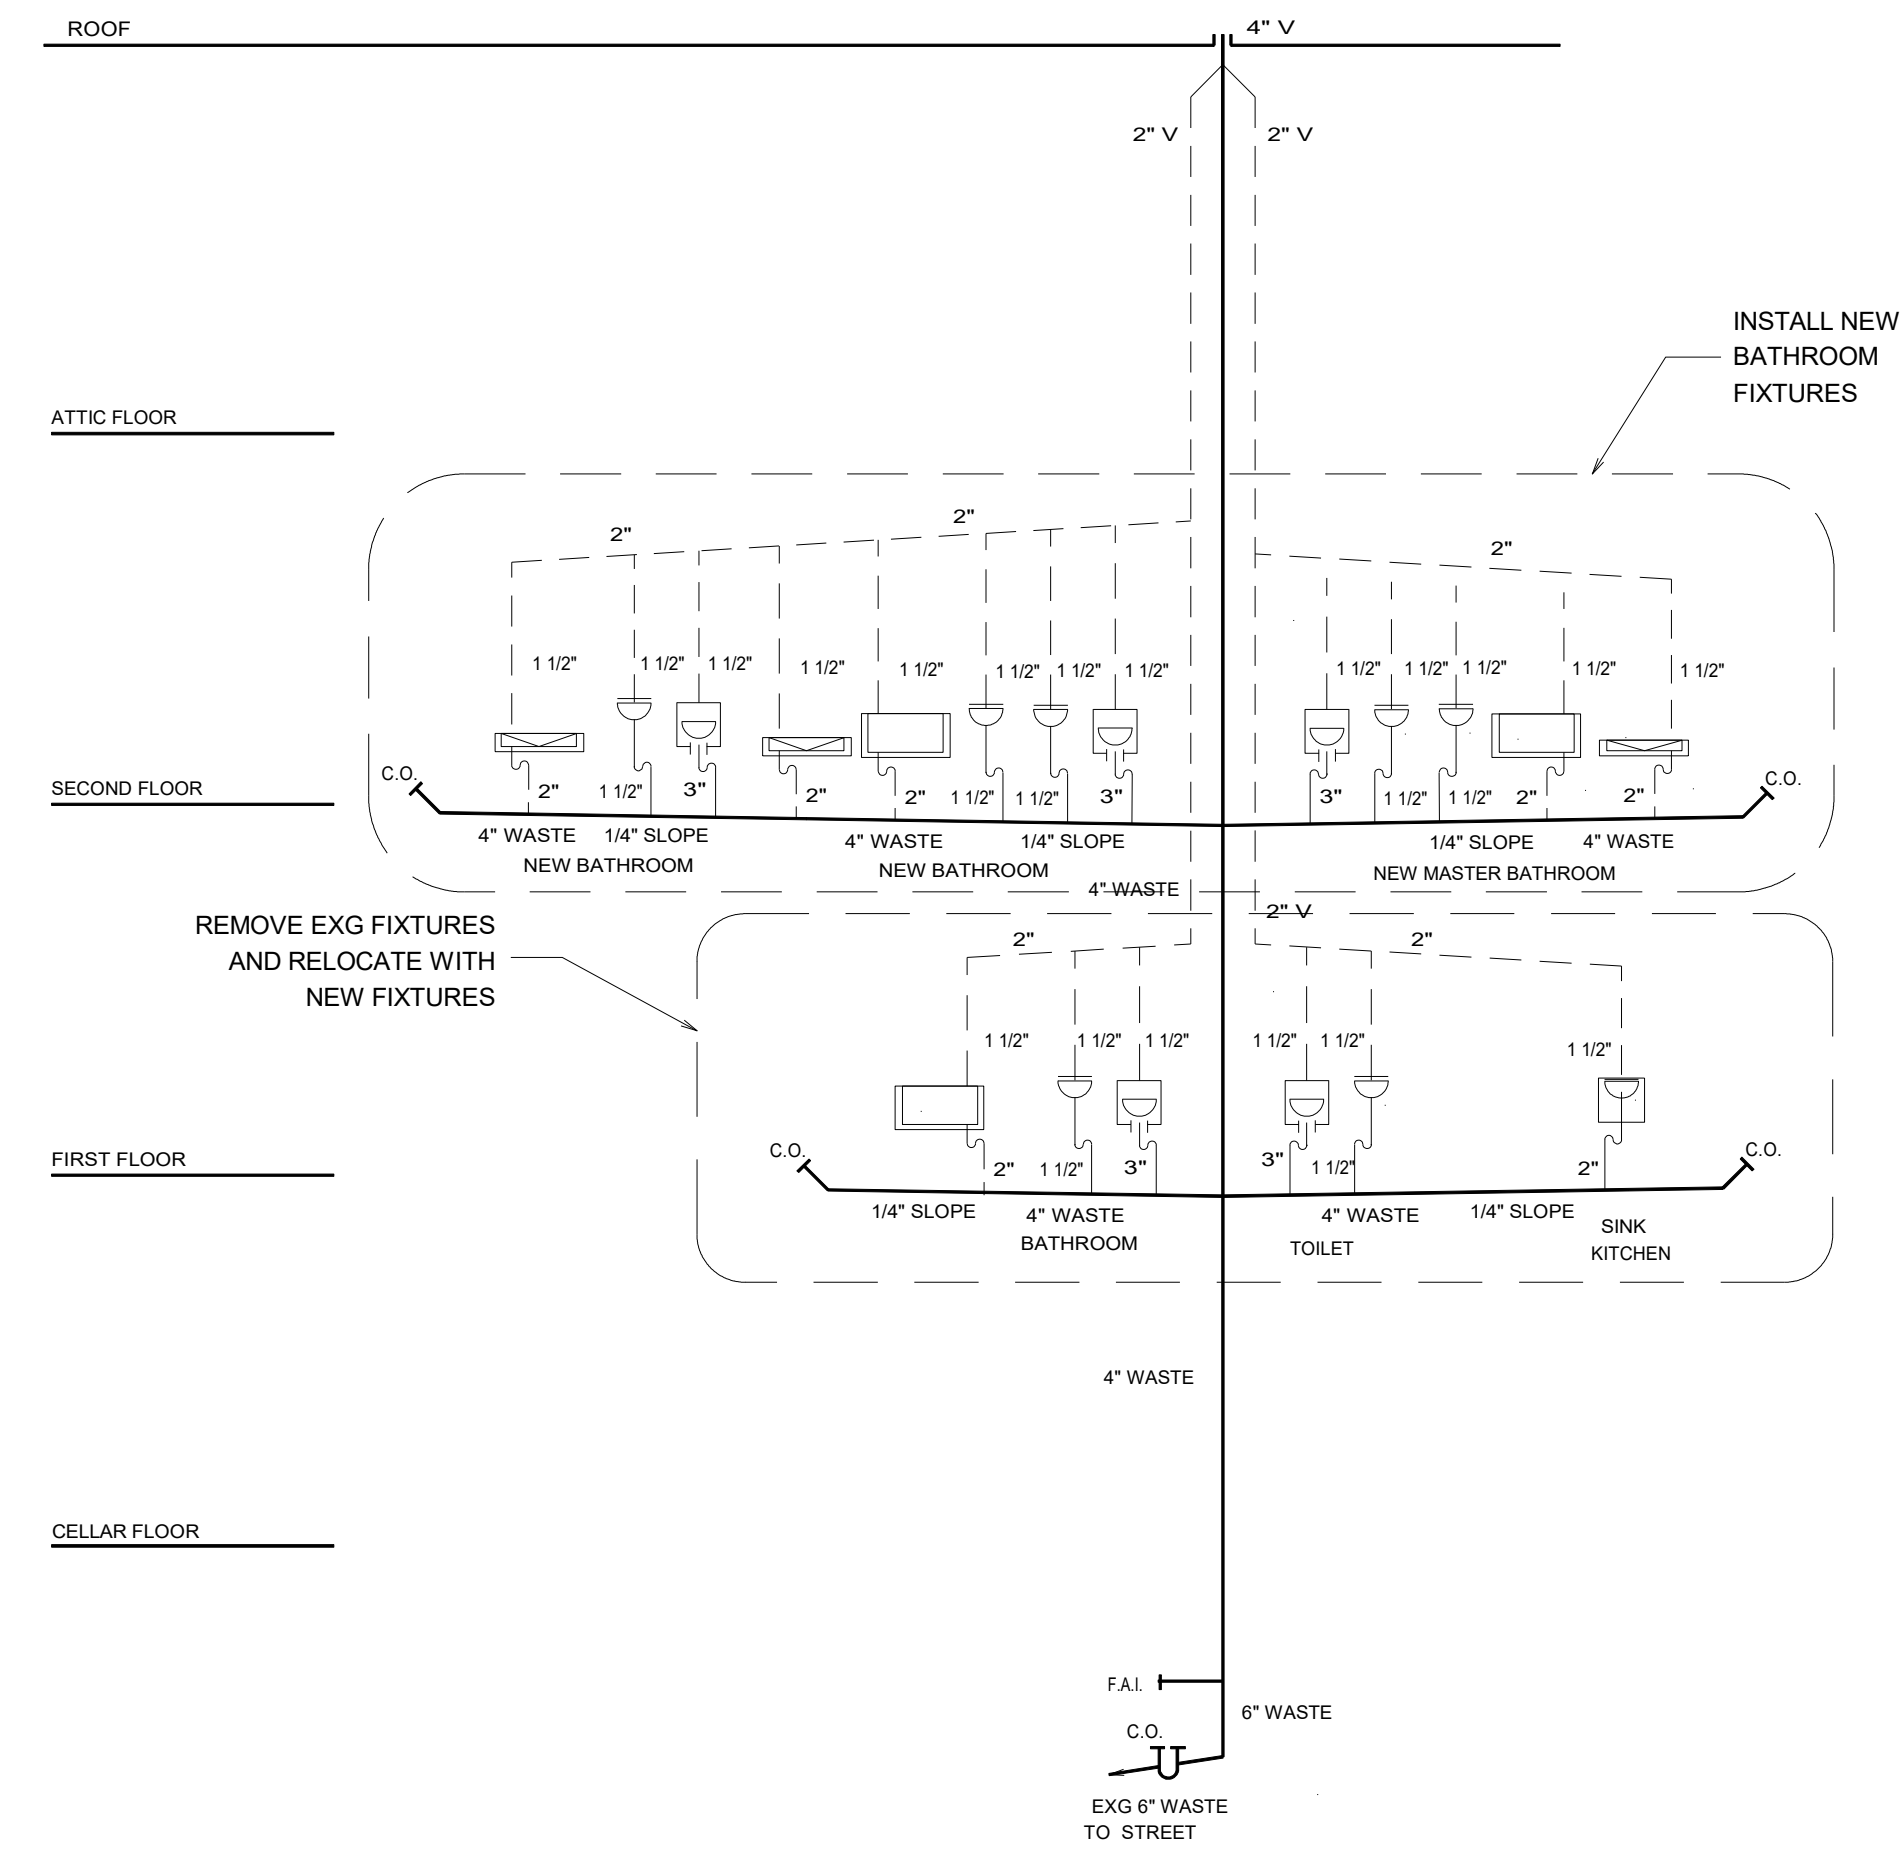

4 PLUMBING RISER DIAGRAM
NOT TO SCALE

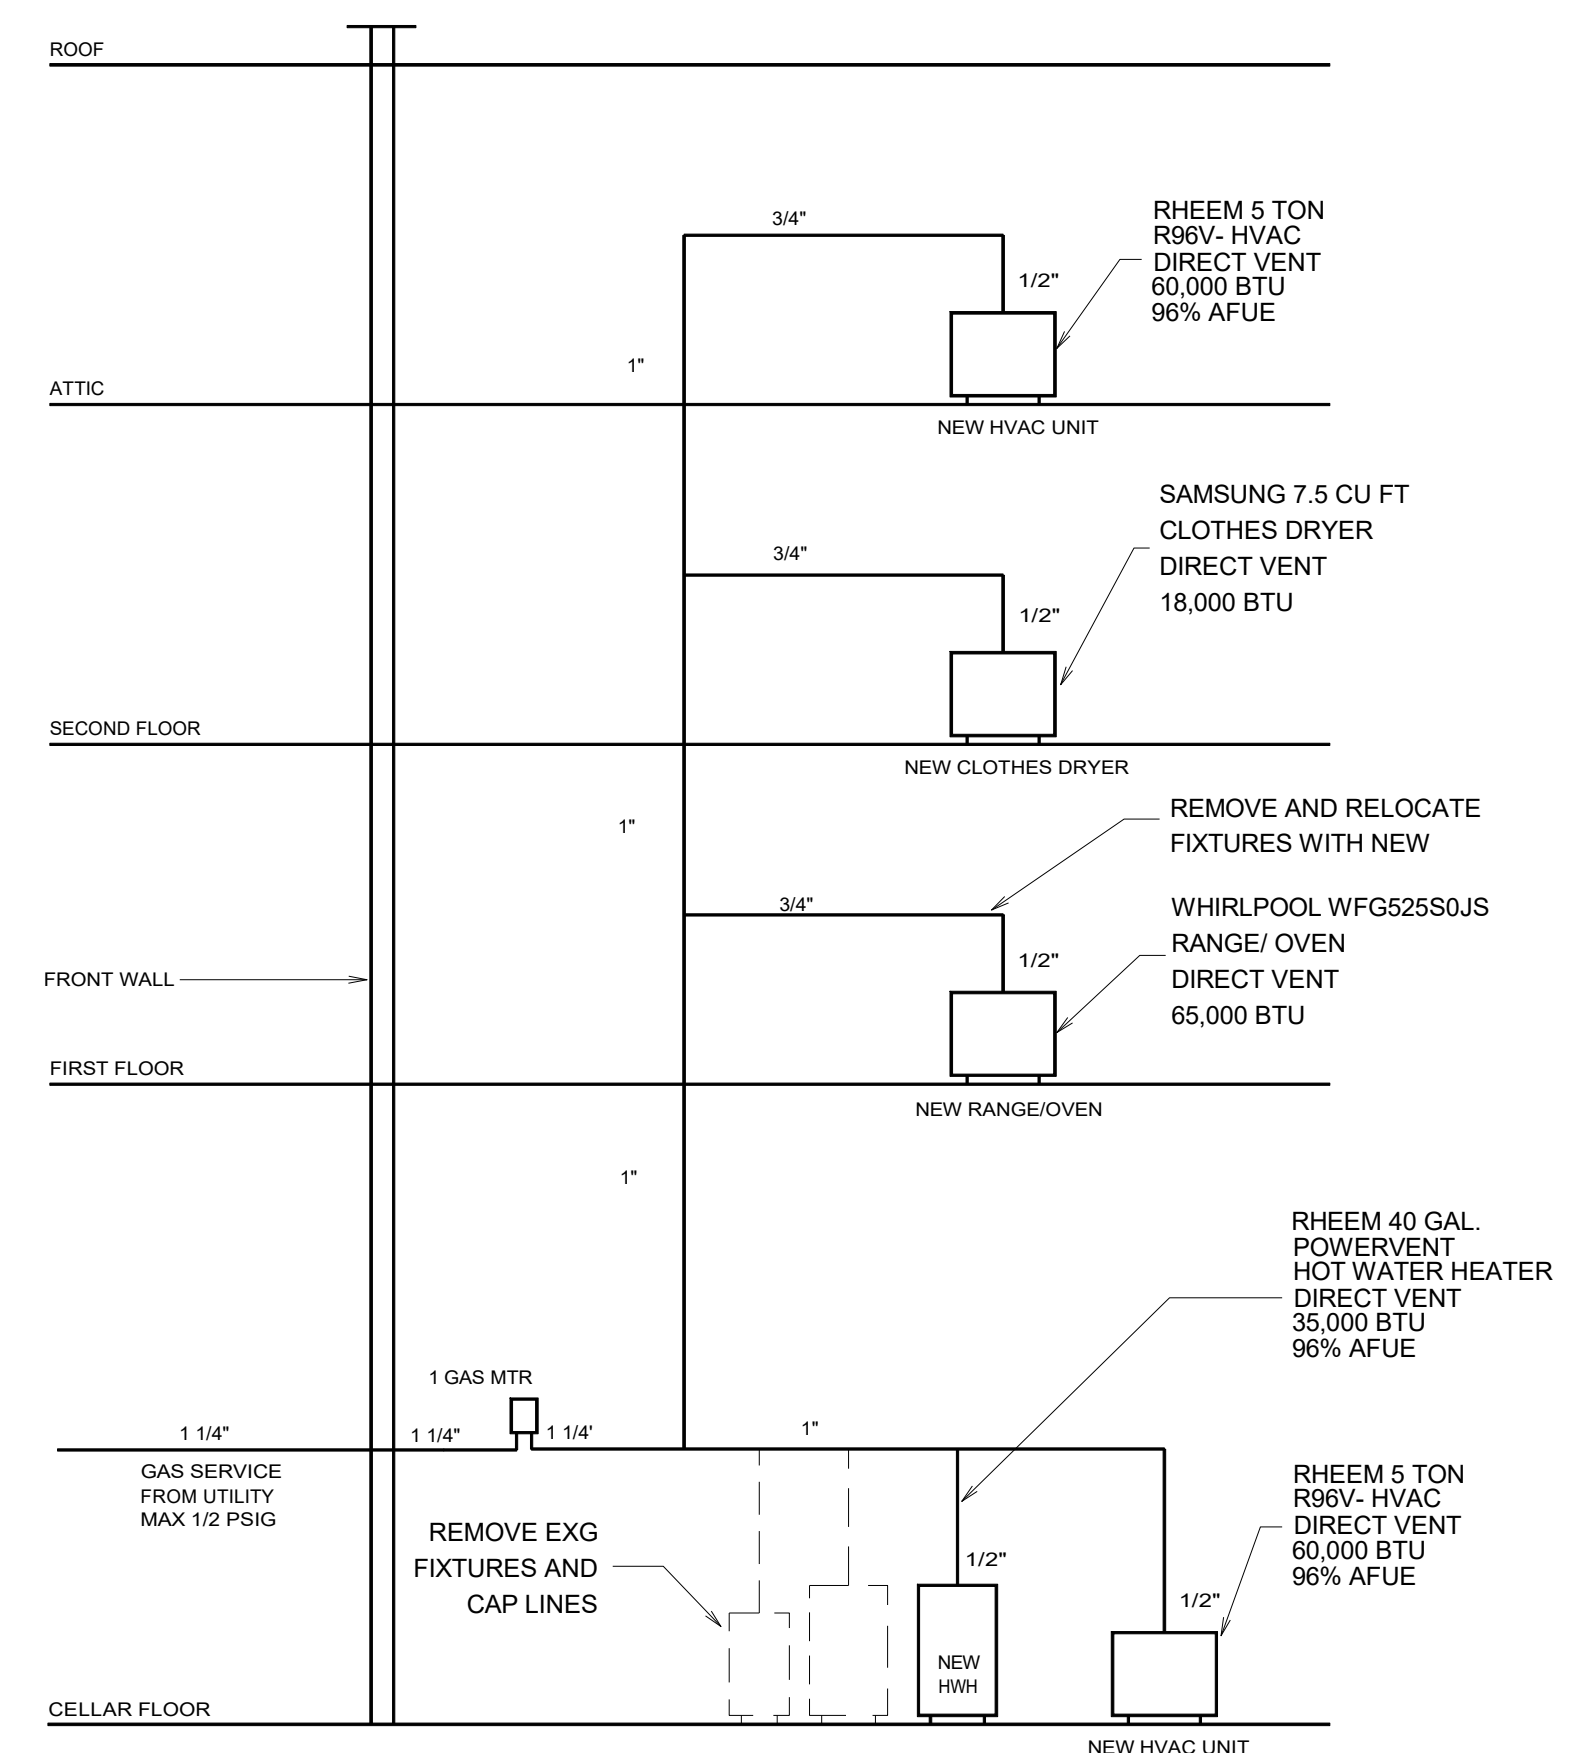

5 GAS RISER DIAGRAM
NOT TO SCALE

JOHN RIGGIO, RA ARCHITECT		PROJECT NO. 202133
172 MAIN STREET, SUITE 33 METUCHEN, NJ 08840 TEL/FAX: (732) 902-2882		DRAWN BY J.R.
		SCALE 1/4" = 1'-0"
SEAL	THE LAW PROHIBITS THE ALTERING OF THIS DOCUMENT TO CHANGE THE DOCUMENT. THERE MUST BE A LICENSED ARCHITECT PRESENT AND ABLE TO SEAL IT.	DATE 4-27-2022
PROJECT ADDITION AND ALTERATION TO ONE FAMILY HOUSE 326 DURHAM AVENUE METUCHEN, NJ 08840	TITLE RISER DIAGRAMS AND DETAILS	DRAWING A-004.00 5 OF 6